

Facilities Planning & Construction

Physical Plant  
 1 University Circle  
 Macomb, IL 61455-1390  
 Phone: 309/298-1834  
 Fax: 309/298-1695

Project Title:

Description:

Location:  
 BROWNE HALL  
 MACOMB, IL

Sheet Title:

Date: 7/12/00

Revised: 6/06/02  
 12/02/08 DLS

Drawn By: SMB

Checked By:



Sheet No.:

**GR-18**

of Sheet(s)

WIU Job Number :

MEZZANINE FLOOR PLAN  
 SCALE : 1" = 20'

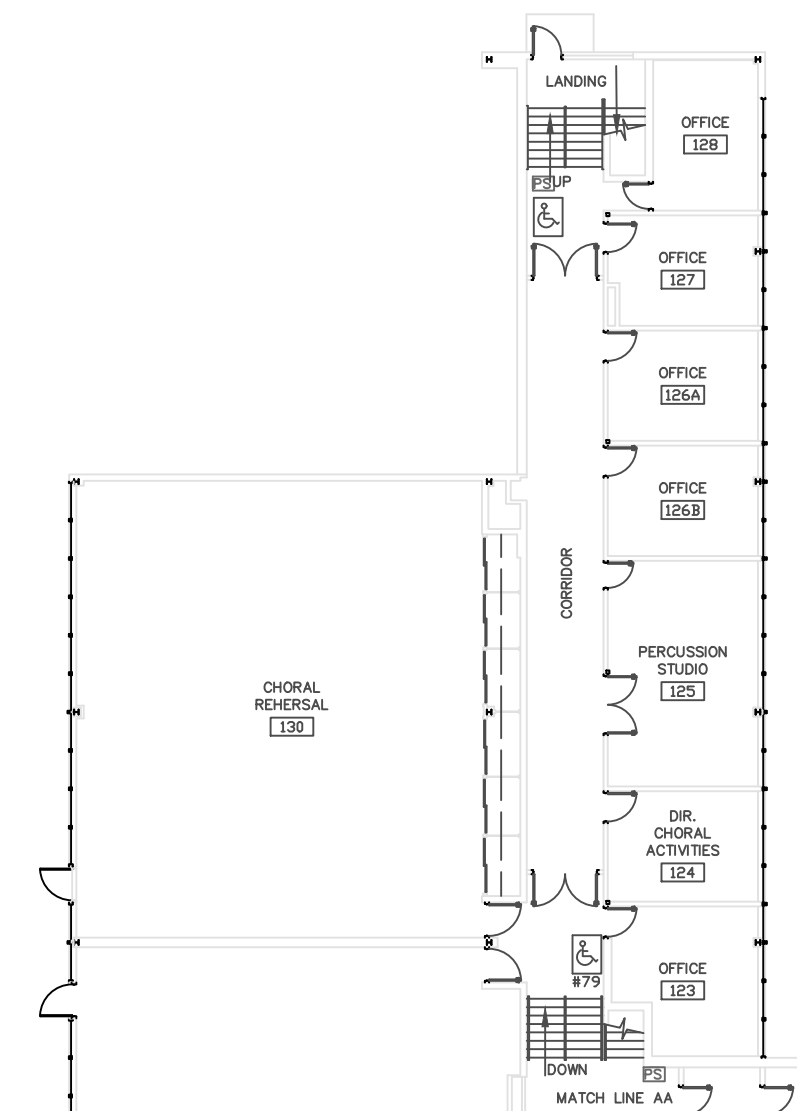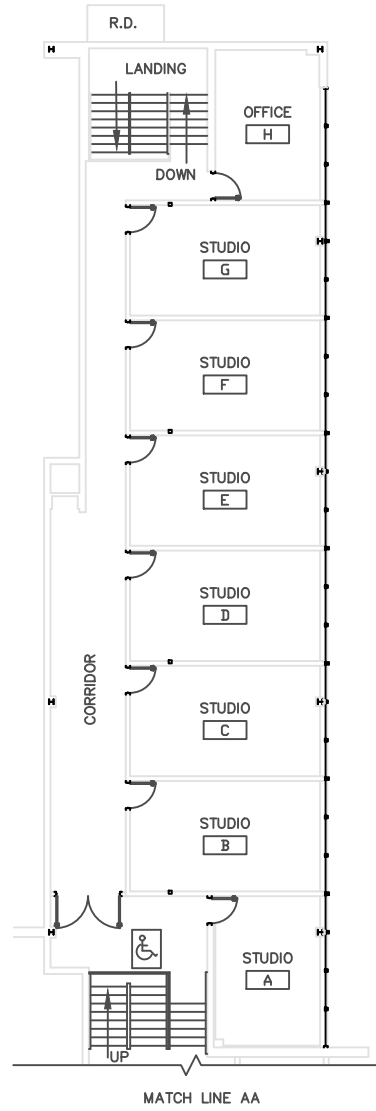

FIRST FLOOR PLAN  
 SCALE : 1" = 20'

