

Facilities Planning & Construction

Physical Plant
1 University Circle
Macomb, IL 61455-1390
Phone: 309/298-1834
Fax: 309/298-1695

Project Title:

Description:

Location:
PHYSICAL PLANT
MACOMB, IL

Sheet Title:



Date: 7/11/00
Revised: 9/24/20 DB

Drawn By: _____
Checked By: _____

Sheet No.
GR-83

of _____ Sheet(s)

WIU Job Number :

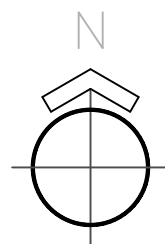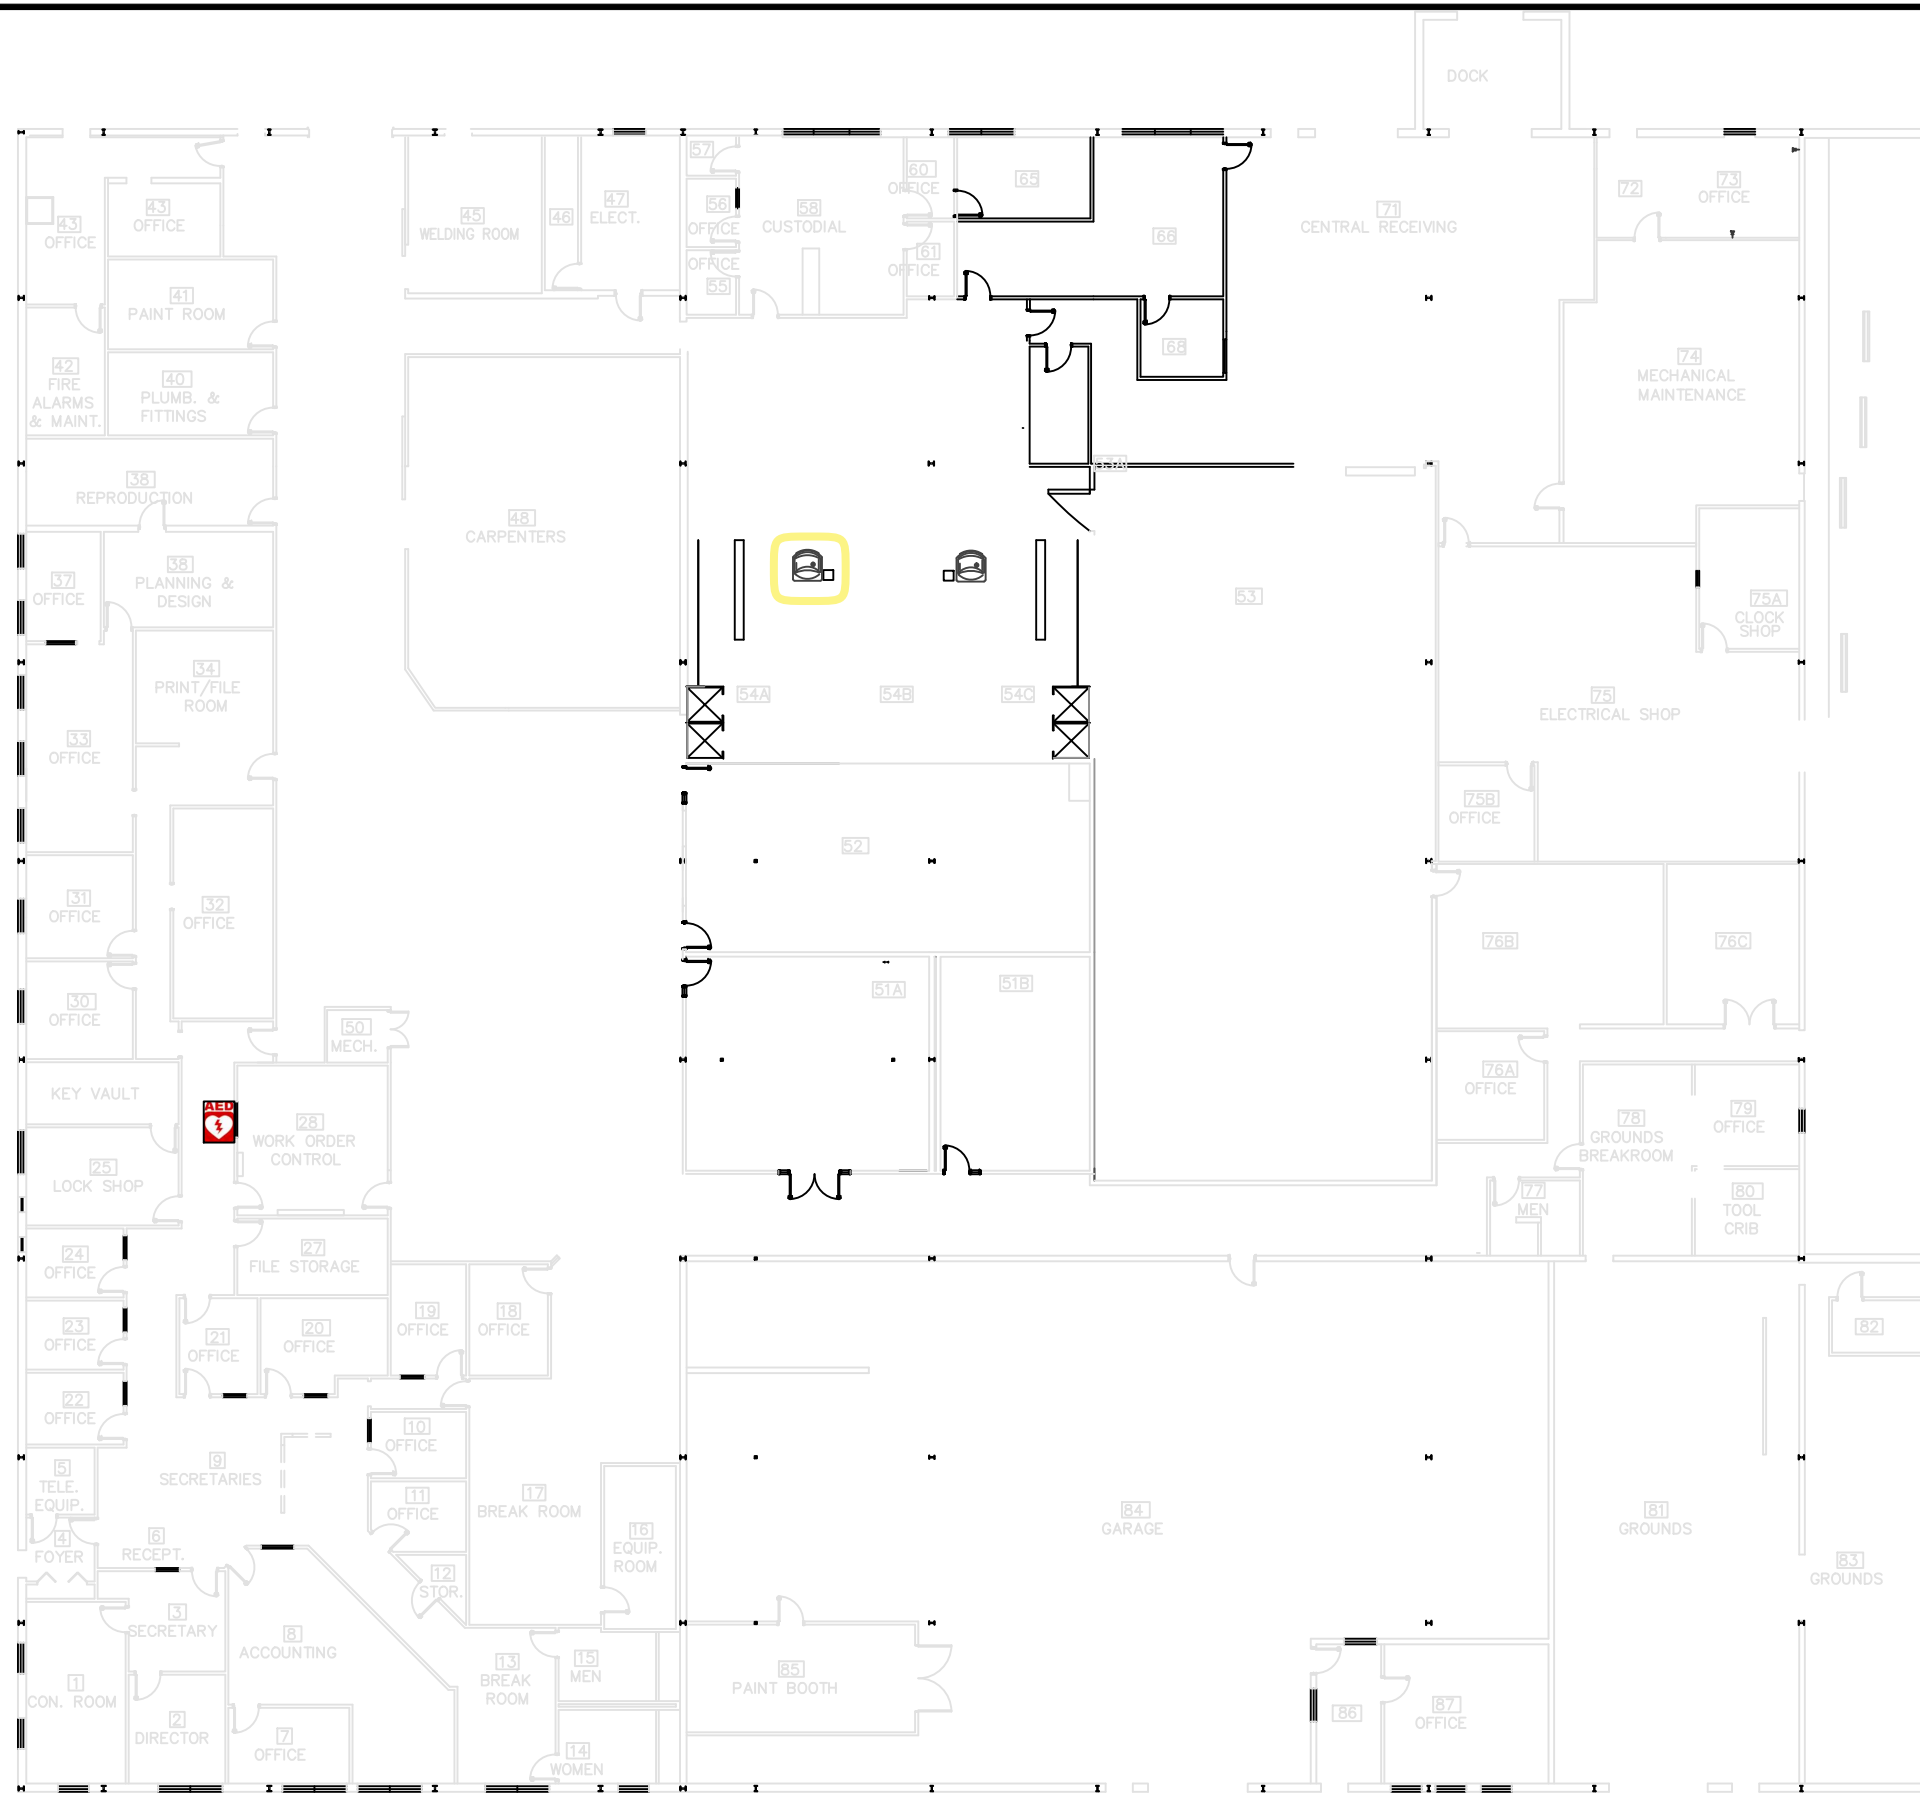

PHYSICAL PLANT SIMPLEX FLOOR PLAN

SCALE : NTS

